



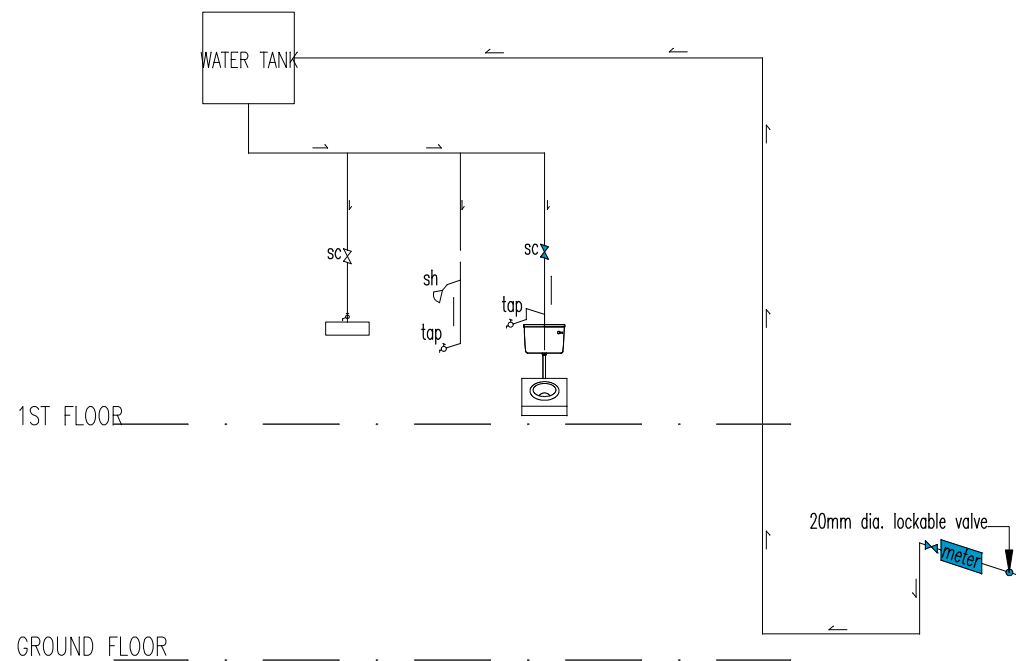


DAIGRAMMATIC LAYOUT OF WATER PIPING

SCALE N.T.S

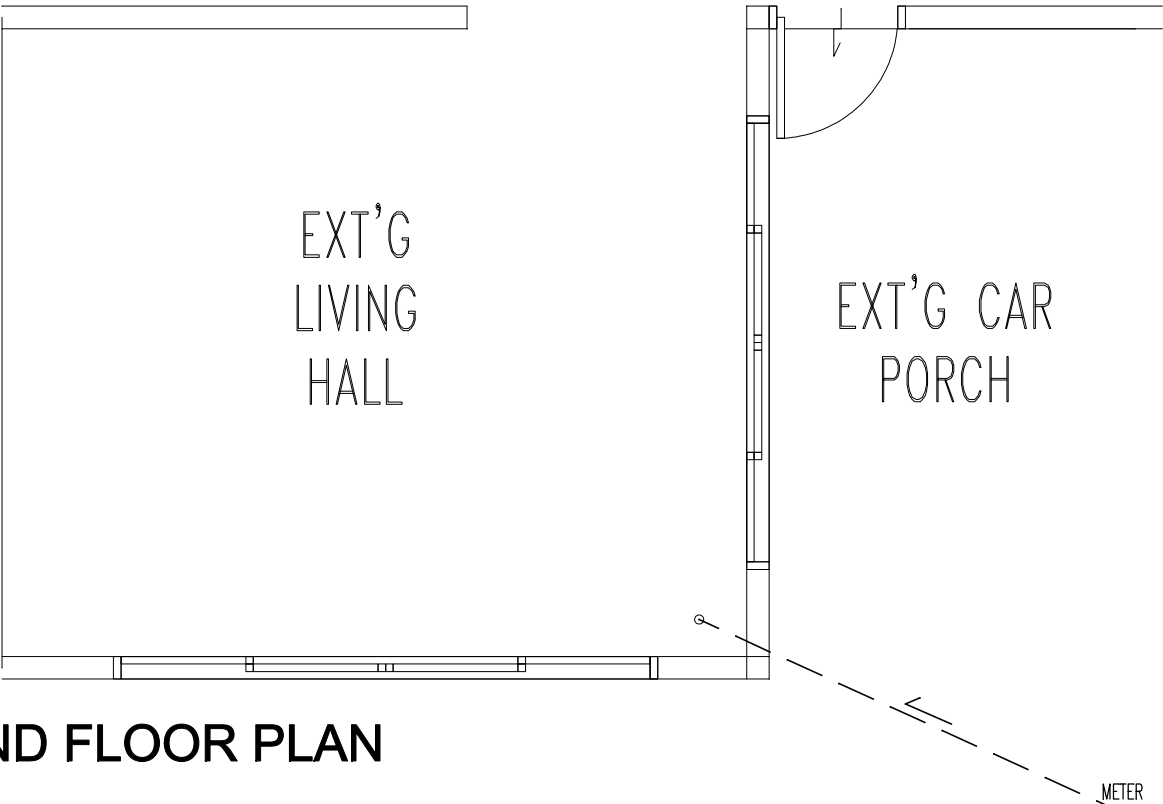

GROUND FLOOR PLAN

SCALE 1:50

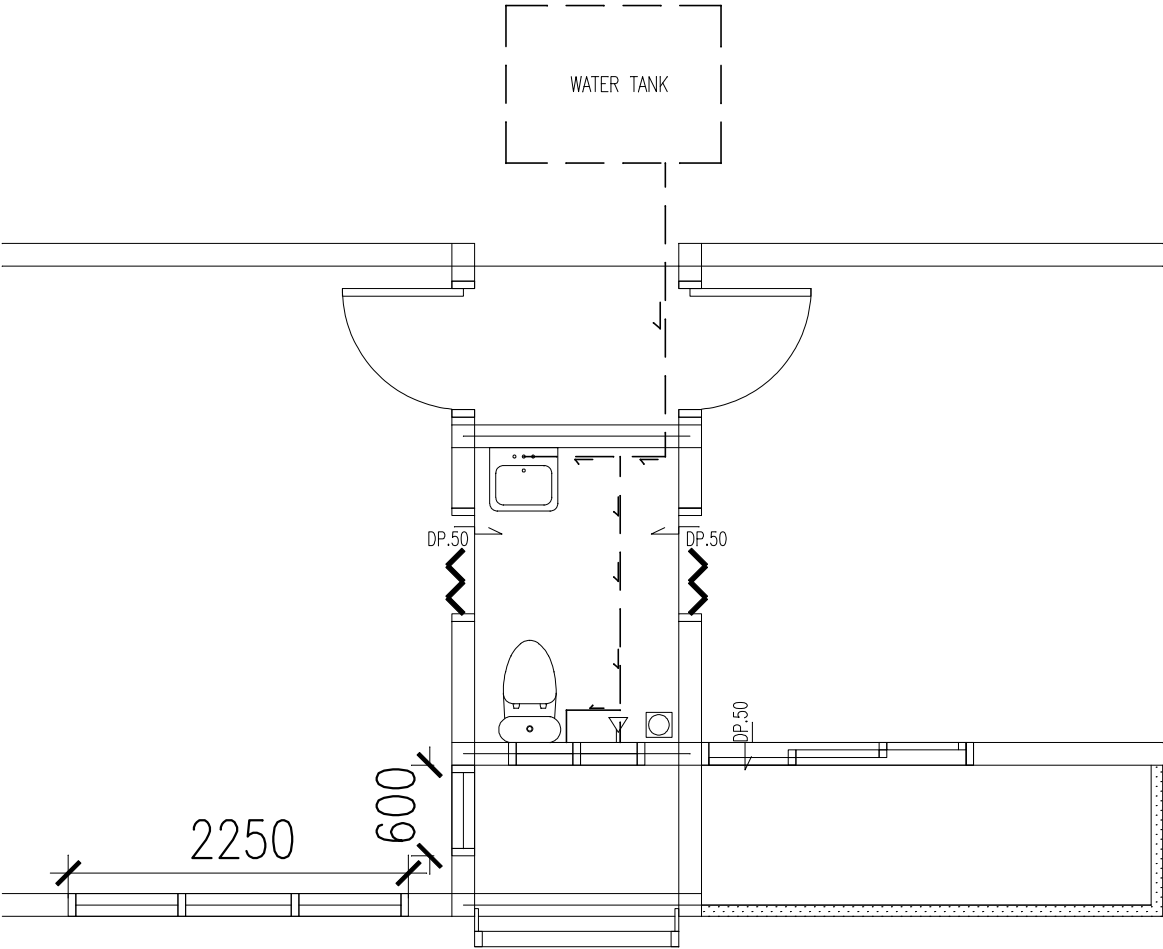

1ST FLOOR PLAN

SCALE 1:50

CONSULTANT:

NR2ARCHI

DESIGN

design • built • consultancy

202103196642 (NS0235897-K)

NO.24-1, JALAN SUSUR MASAI LAMA 1,

TAMAN SAUJANA, 81100 JOHOR BAHRU,

JOHOR DARUL TA'ZIM

TEL: 011-63611050

EMAIL: nr2arch@gmail.com

Title :
PERMOHONAN CADANGAN TAMBAHAN UBAHAN
KEATAS RUMAH BERKEMBAR 1 1/2 TINGKAT SEDIA ADA
DI NO. 17, JALAN PUCUNG 5, TAMAN PERLING,
DI ATAS PTD 28879 (LOT 27090),
MUKIM PULAI, DAERAH JOHOR BAHRU, JOHOR DARUL TAKZIM
TETUAN MOHAMAD SAIFULDIN BIN ZULKIFLI

Drawing Title :
DAIGRAMMATIC LAYOUT
OF WATER PIPING

AMENDMENTS :

FILE NAME : DR. SAIFULDIN/06/01/CONSTRUCTION/DETAIL DRAWINGS

SCALE : AS-SHOWN

DATE : APRIL 2022

DRAWN BY : KHAI

CHECK BY :REMMY

JOB NO.: DR. SAIFULDIN/CONSTRUCTION

DWG NO. :WP/G100

01